


FLOOR PLAN
SCALE: 1/4" = 1'

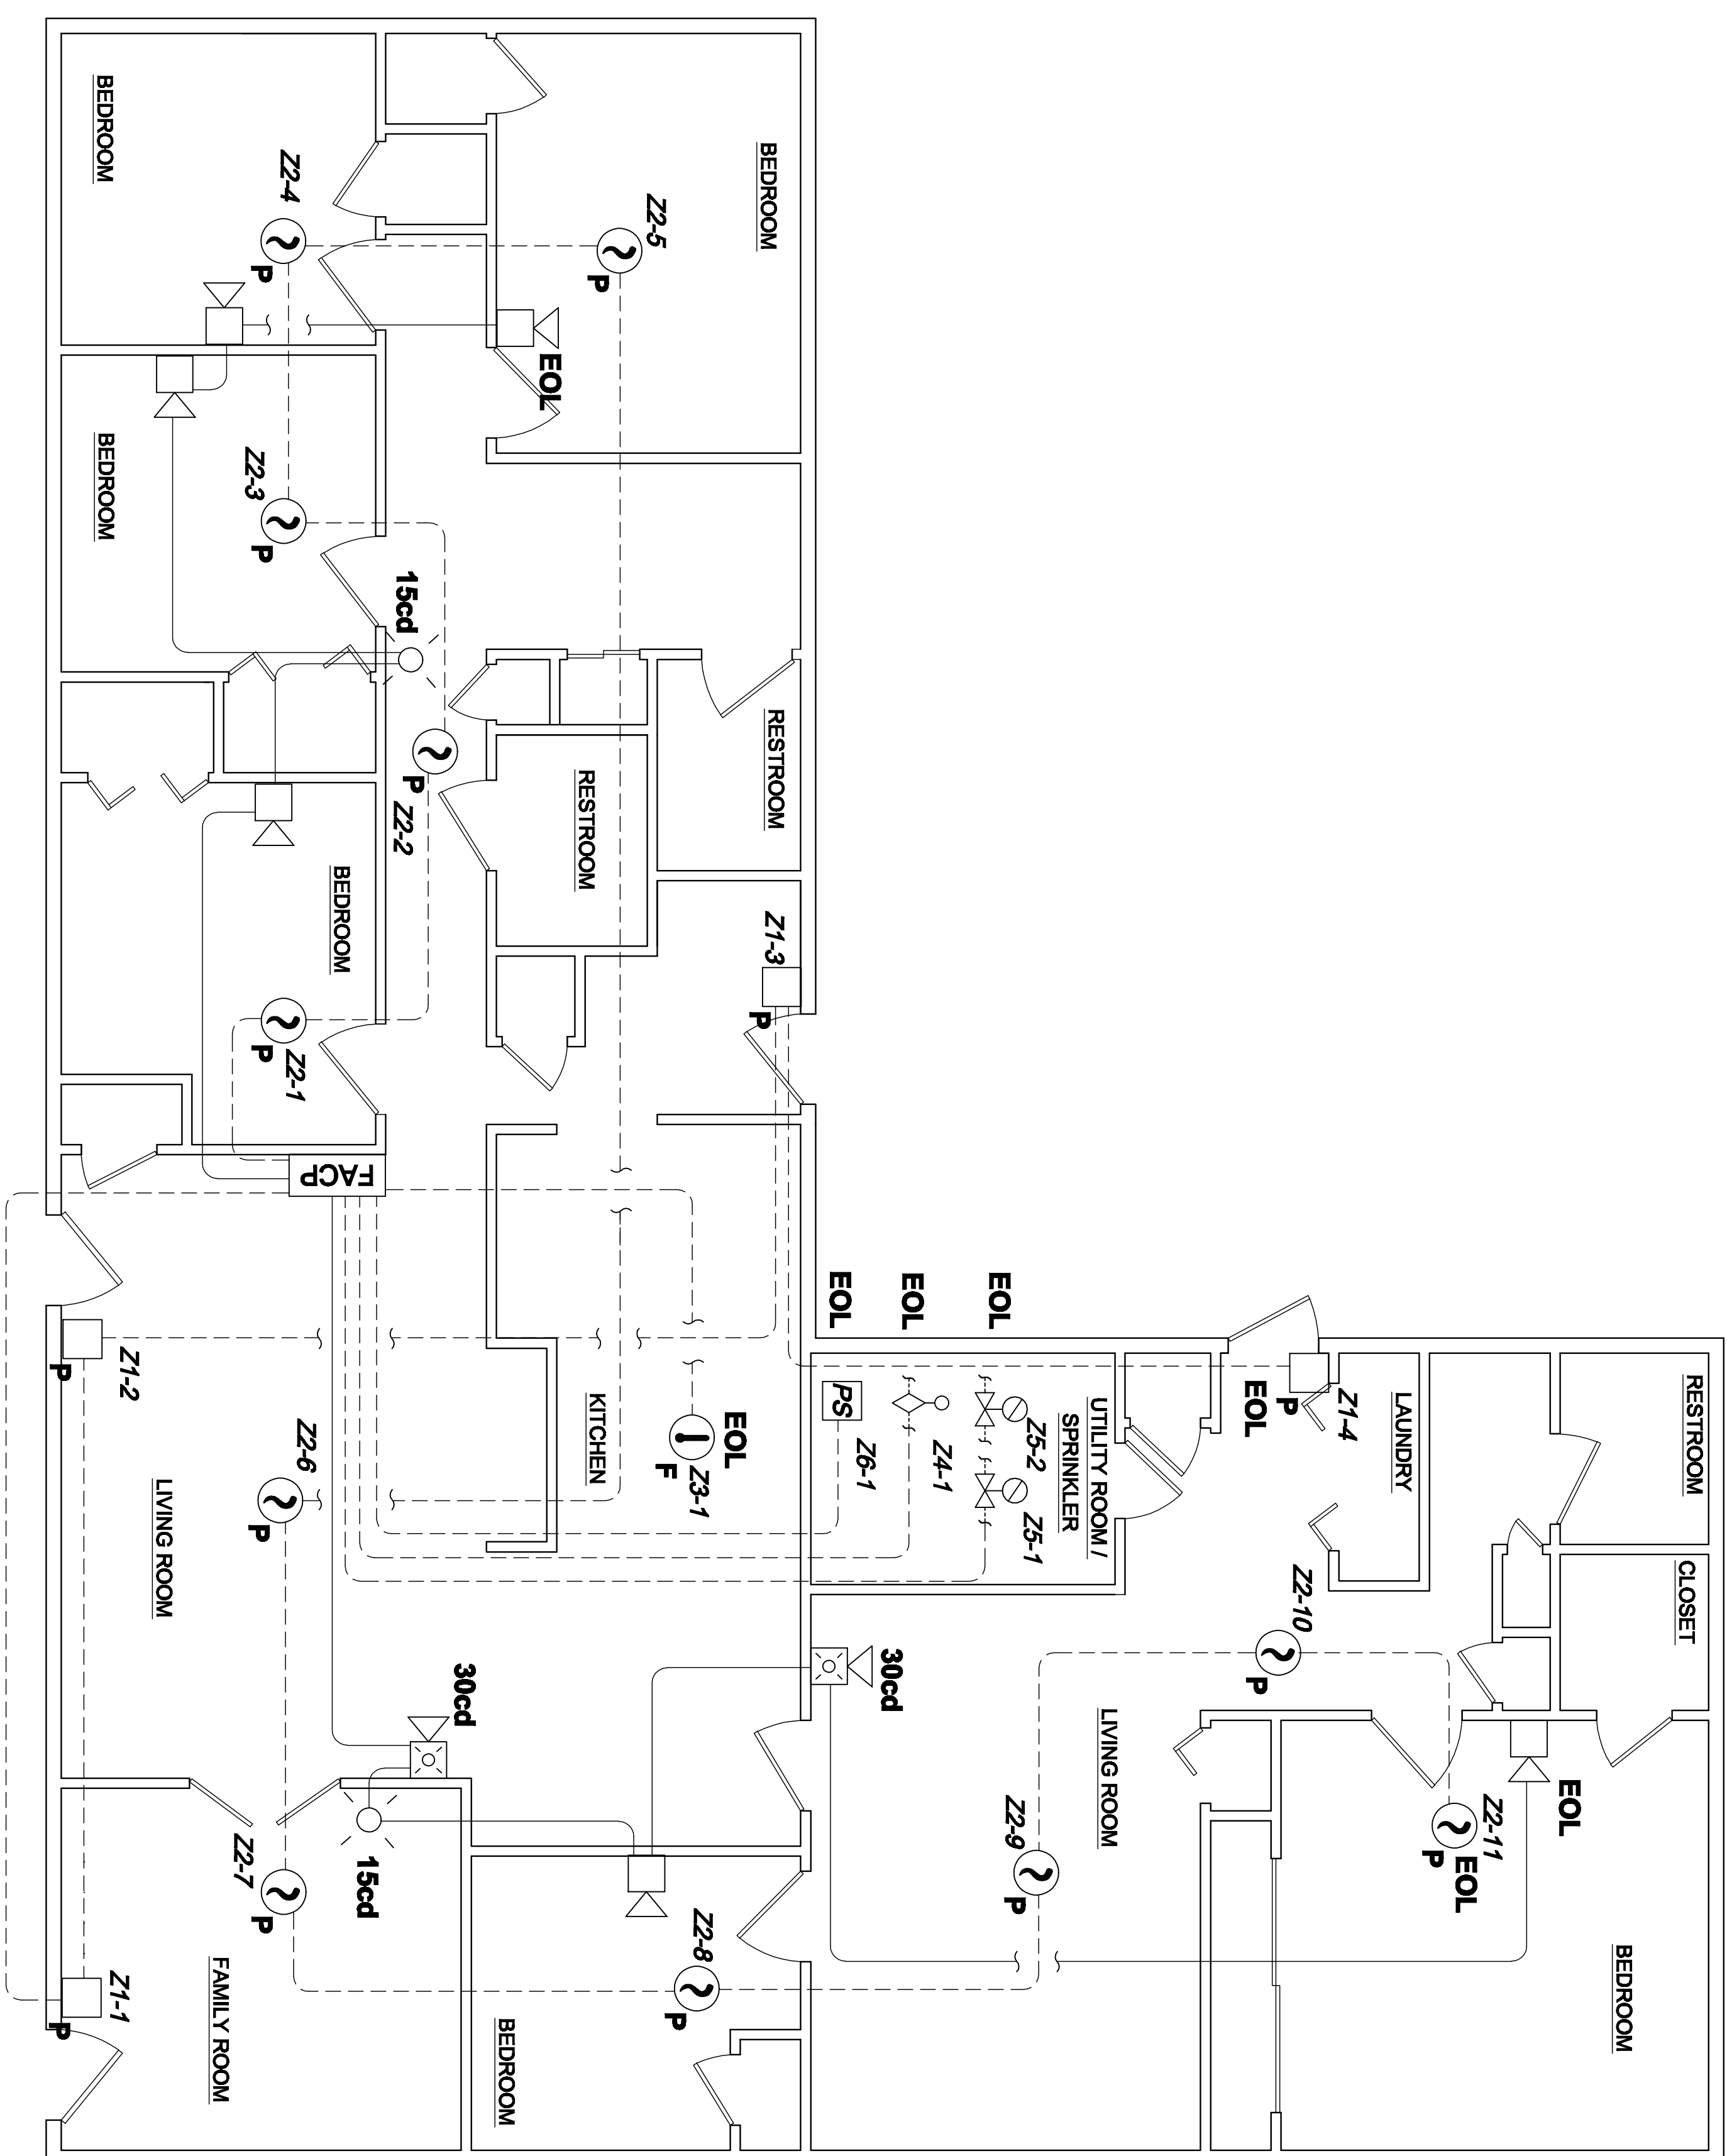

116837

BILL GARRISON, SET
FIRE ALARM SYSTEMS

YOUR COMPANY HERE
YOUR STREET ADDRESS
YOUR TOWN, YOUR STATE, USA
PHONE: (555) 555-1234
FAX: (555) 555-1235

SYSTEM DESIGNER & INSTALLER:
YOUR LOGO HERE

XYZ FACILITY
XYZ Drive
Anywhere, Colorado 80910

DATE OF REVISION	22 SEPT 2011
PROJECT #	XXXX
SHEET DESCRIPTION	FLOOR PLAN DEVICE LAYOUT
SHEET NUMBER	FA-3